




GROUND FLOOR PLAN

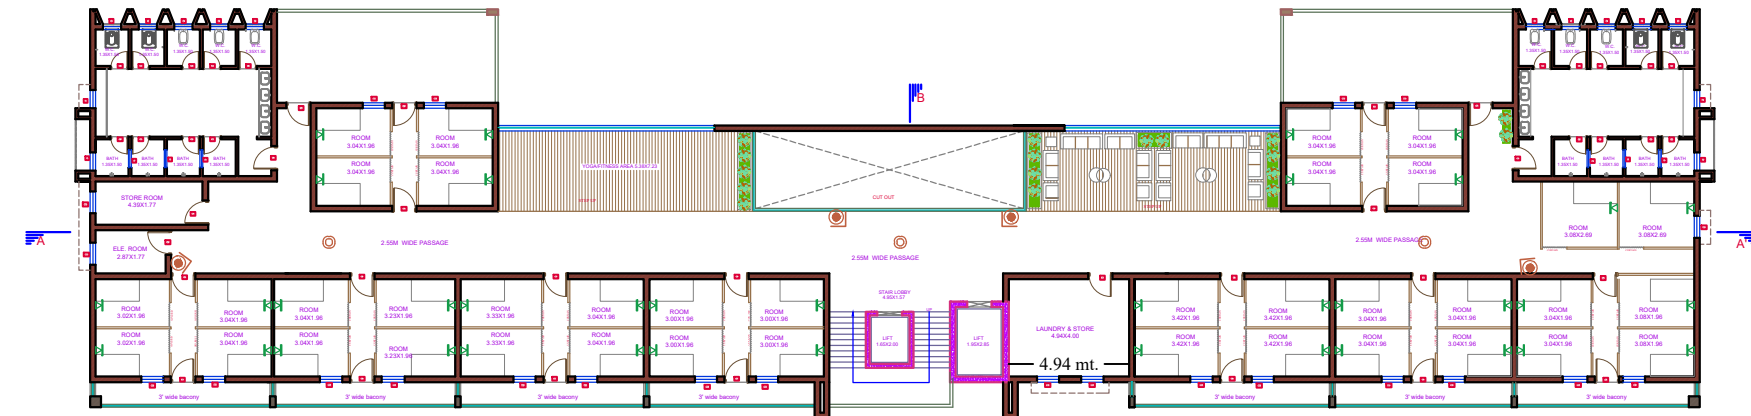

FIRST FLOOR PLAN

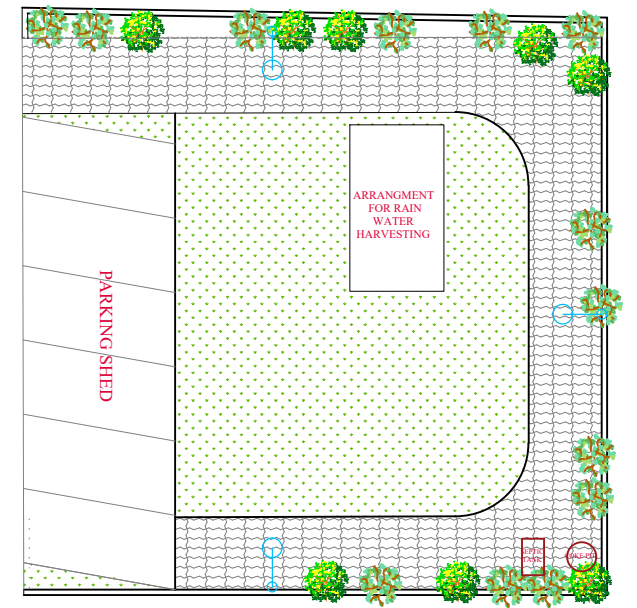

SECOND FLOOR PLAN

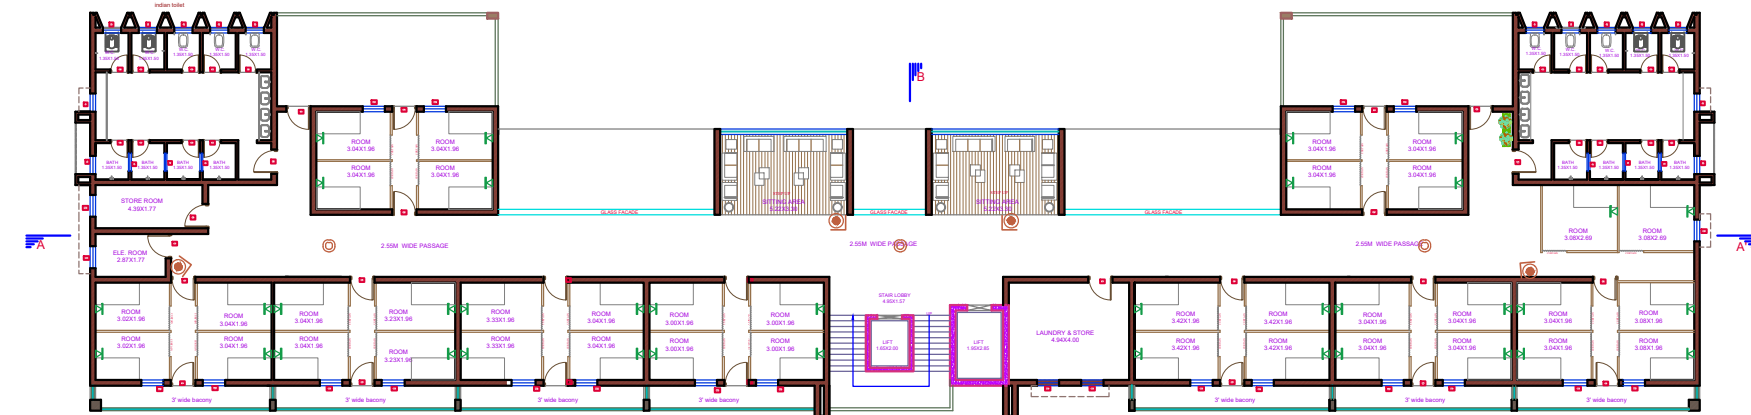

THIRD FLOOR PLAN

GENERAL NOTES

1. All dimension on the drawings are in meter unless mention otherwise.
2. All levels are marked from finished floor level unless mentioned otherwise.
3. Dimension on the drawings are not be scaled, only stated dimension are to be followed.
4. All dimension shall be verified on site prior to start of work, only discrepancy shall be brought to the notice of the engineer in charge.
5. All the proposed openings such as door, window and cutouts are opening from plaster to plaster.

| LEGEND | | |
|--------|--------------------------------|--------|
| NO. | NAME | SYMBOL |
| 18 | STREET LIGHT POLE AND FITTINGS | |
| 19 | TELEPHONE | |
| 20 | DOME CAMERA | |
| 21 | BULLET CAMERA | |
| 22 | PITZ CAMERA | |
| 23 | WIFI ROUTER | |
| 24 | T.V. | |
| 25 | UPS 3 KVA | |
| 26 | EPBX | |
| 27 | TSU RACK | |

radhe DEDICATED FREIGHT CORRIDOR CORPORATION OF INDIA LTD.

NAME OF WORK: CONSTRUCTION OF RUNNING ROOM AT NEW PALANPUR UNDER COM OF COIL, AAI UNIT

TITLE: GENERAL ARRANGEMENT DRAWING FOR RUNNING ROOM AT NEW PALANPUR

STATION: NEW PALANPUR (WDFC)

CONSULTANT: RADHE INFRA TECH

DRG. NO: HR-05

NOT TO SCALE

| | | | | | |
|------|----|---------|------|----|---------|
| DATE | BY | CHECKED | DATE | BY | CHECKED |
| | | | | | |