


OPEN MARGIN

150x300MM OUT OUT IN
SLAB FOR CABLE ROUTE
TO UPPER FLOORS

ROAD 6.00 mt WIDE


SERVICE TRENCH

ELECTRICAL LAYOUT FOR GROUND FLOOR PLAN

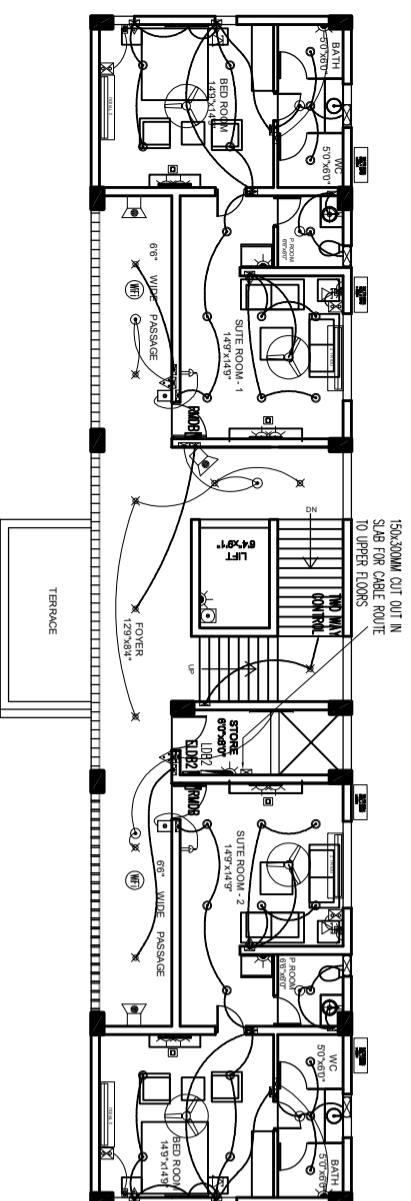


150x300MM OUT OUT IN
SLAB FOR CABLE ROUTE
TO UPPER FLOORS

ELECTRICAL LAYOUT FOR FIRST FLOOR PLAN

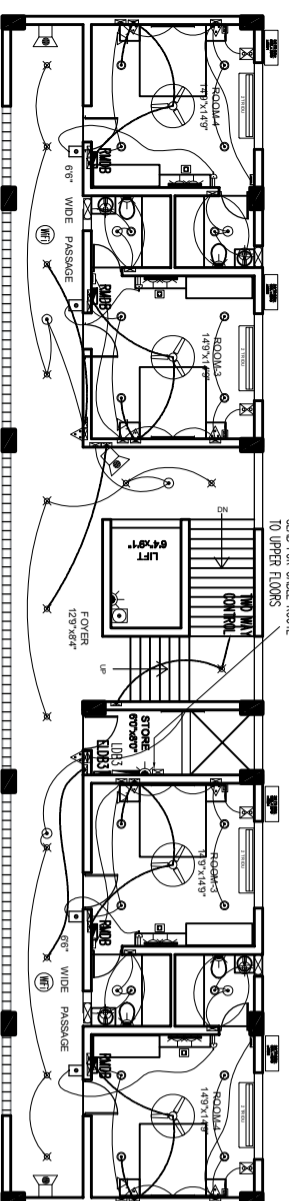

150x300MM OUT OUT IN
SLAB FOR CABLE ROUTE
TO UPPER FLOORS

ELECTRICAL LAYOUT FOR SECOND FLOOR PLAN

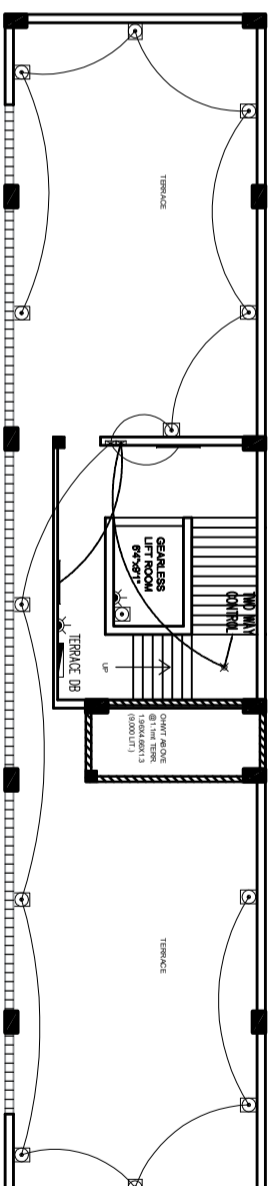

ELECTRICAL LAYOUT FOR TERRACE FLOOR PLAN

ELECTRICAL LEGEND:		
SYMBOL/DESCRIPTION	SYMBOL/DESCRIPTION	SYMBOL/DESCRIPTION
SWITCH BOARD	2XW LED LIGHT - 4' LONG	BELL PUSH
BA ON BOARD SOCKET	MOTION SENSOR	BELL BUZZER
5A POWER SOCKET	4" DIA CEILING FAN	DATA POINT
15A POWER SOCKET	3" DIA CEILING FAN	EXHAUST FAN
AC WIRE OUTLET	10W WALL BRACKET LIGHT	NIGHT LIGHT -MODULER TYPE
15A AC POWER SWITCH	220W WALL LIGHT/OUTDOOR	CCTV POINT
15W DOWN LIGHT	TELEVISION CORD OUTLET	7W PLANTER LIGHT/SPIKE LIGHT
15W DOWN LIGHT	TELEPHONE POINT	EMERGENCY LIGHTING SB
15W DOWN LIGHT		5A SOCKET ON EMER. POWER
5A UPS POWER SOCKET		

BUILT UP AREA TABLE		SQ. MT.
TOTAL BUILT UP AREA	=	782.00 SQ.MT.
BUILT UP AREA GF FLOOR	=	260.00 SQ.MT.
BUILT UP AREA FF FLOOR	=	236.00 SQ.MT.
BUILT UP AREA SF FLOOR	=	236.00 SQ.MT.
BUILT UP AREA CABIN FLOOR	=	60.00 SQ.MT.

R-0	05/08/23	FOR TENDER PURPOSE
REV. NO.	DATE	PARTICULARS
R E V I S I O N S		

NOTES:-
- ALL DIMENSIONS ARE IN METRES.
- IF ANY AMBIGUITY FOUND SHALL BE BROUGHT TO NOTICE TO ARCHITECT.

PROJECT
OFFICER REST HOUSE (ORH) AT
CGM OFFICE
AHMEDABAD

DRG. TITLE	
PLOT PLAN & ALL FLOOR PLAN	
SCALE : N.T.S	
DATE : 05/08/23	
DEALT : SACHIN	
CHECK : HAP	
CLIENT	
E / 1.0	R / 00

DEDICATED FREIGHT CORRIDOR
OF INDIA LTD.
CHIEF GENERAL MANAGERS'S OFFICE
OGC BULDING. SABARMATI,
AHMEDABAD 380019
CONSULTANTS

AKSHAR CORPORATION
ARCHITECTS + STRUCTURAL DESIGNERS
24, THIRD FLOOR, SHUKAN MALL, SHAHBAUG, AHMEDABAD 04
PHONE : +91 79 020214, 9978817194
E-Mail : akshar_ahmedabad@akshar.com