


FUTUTRE

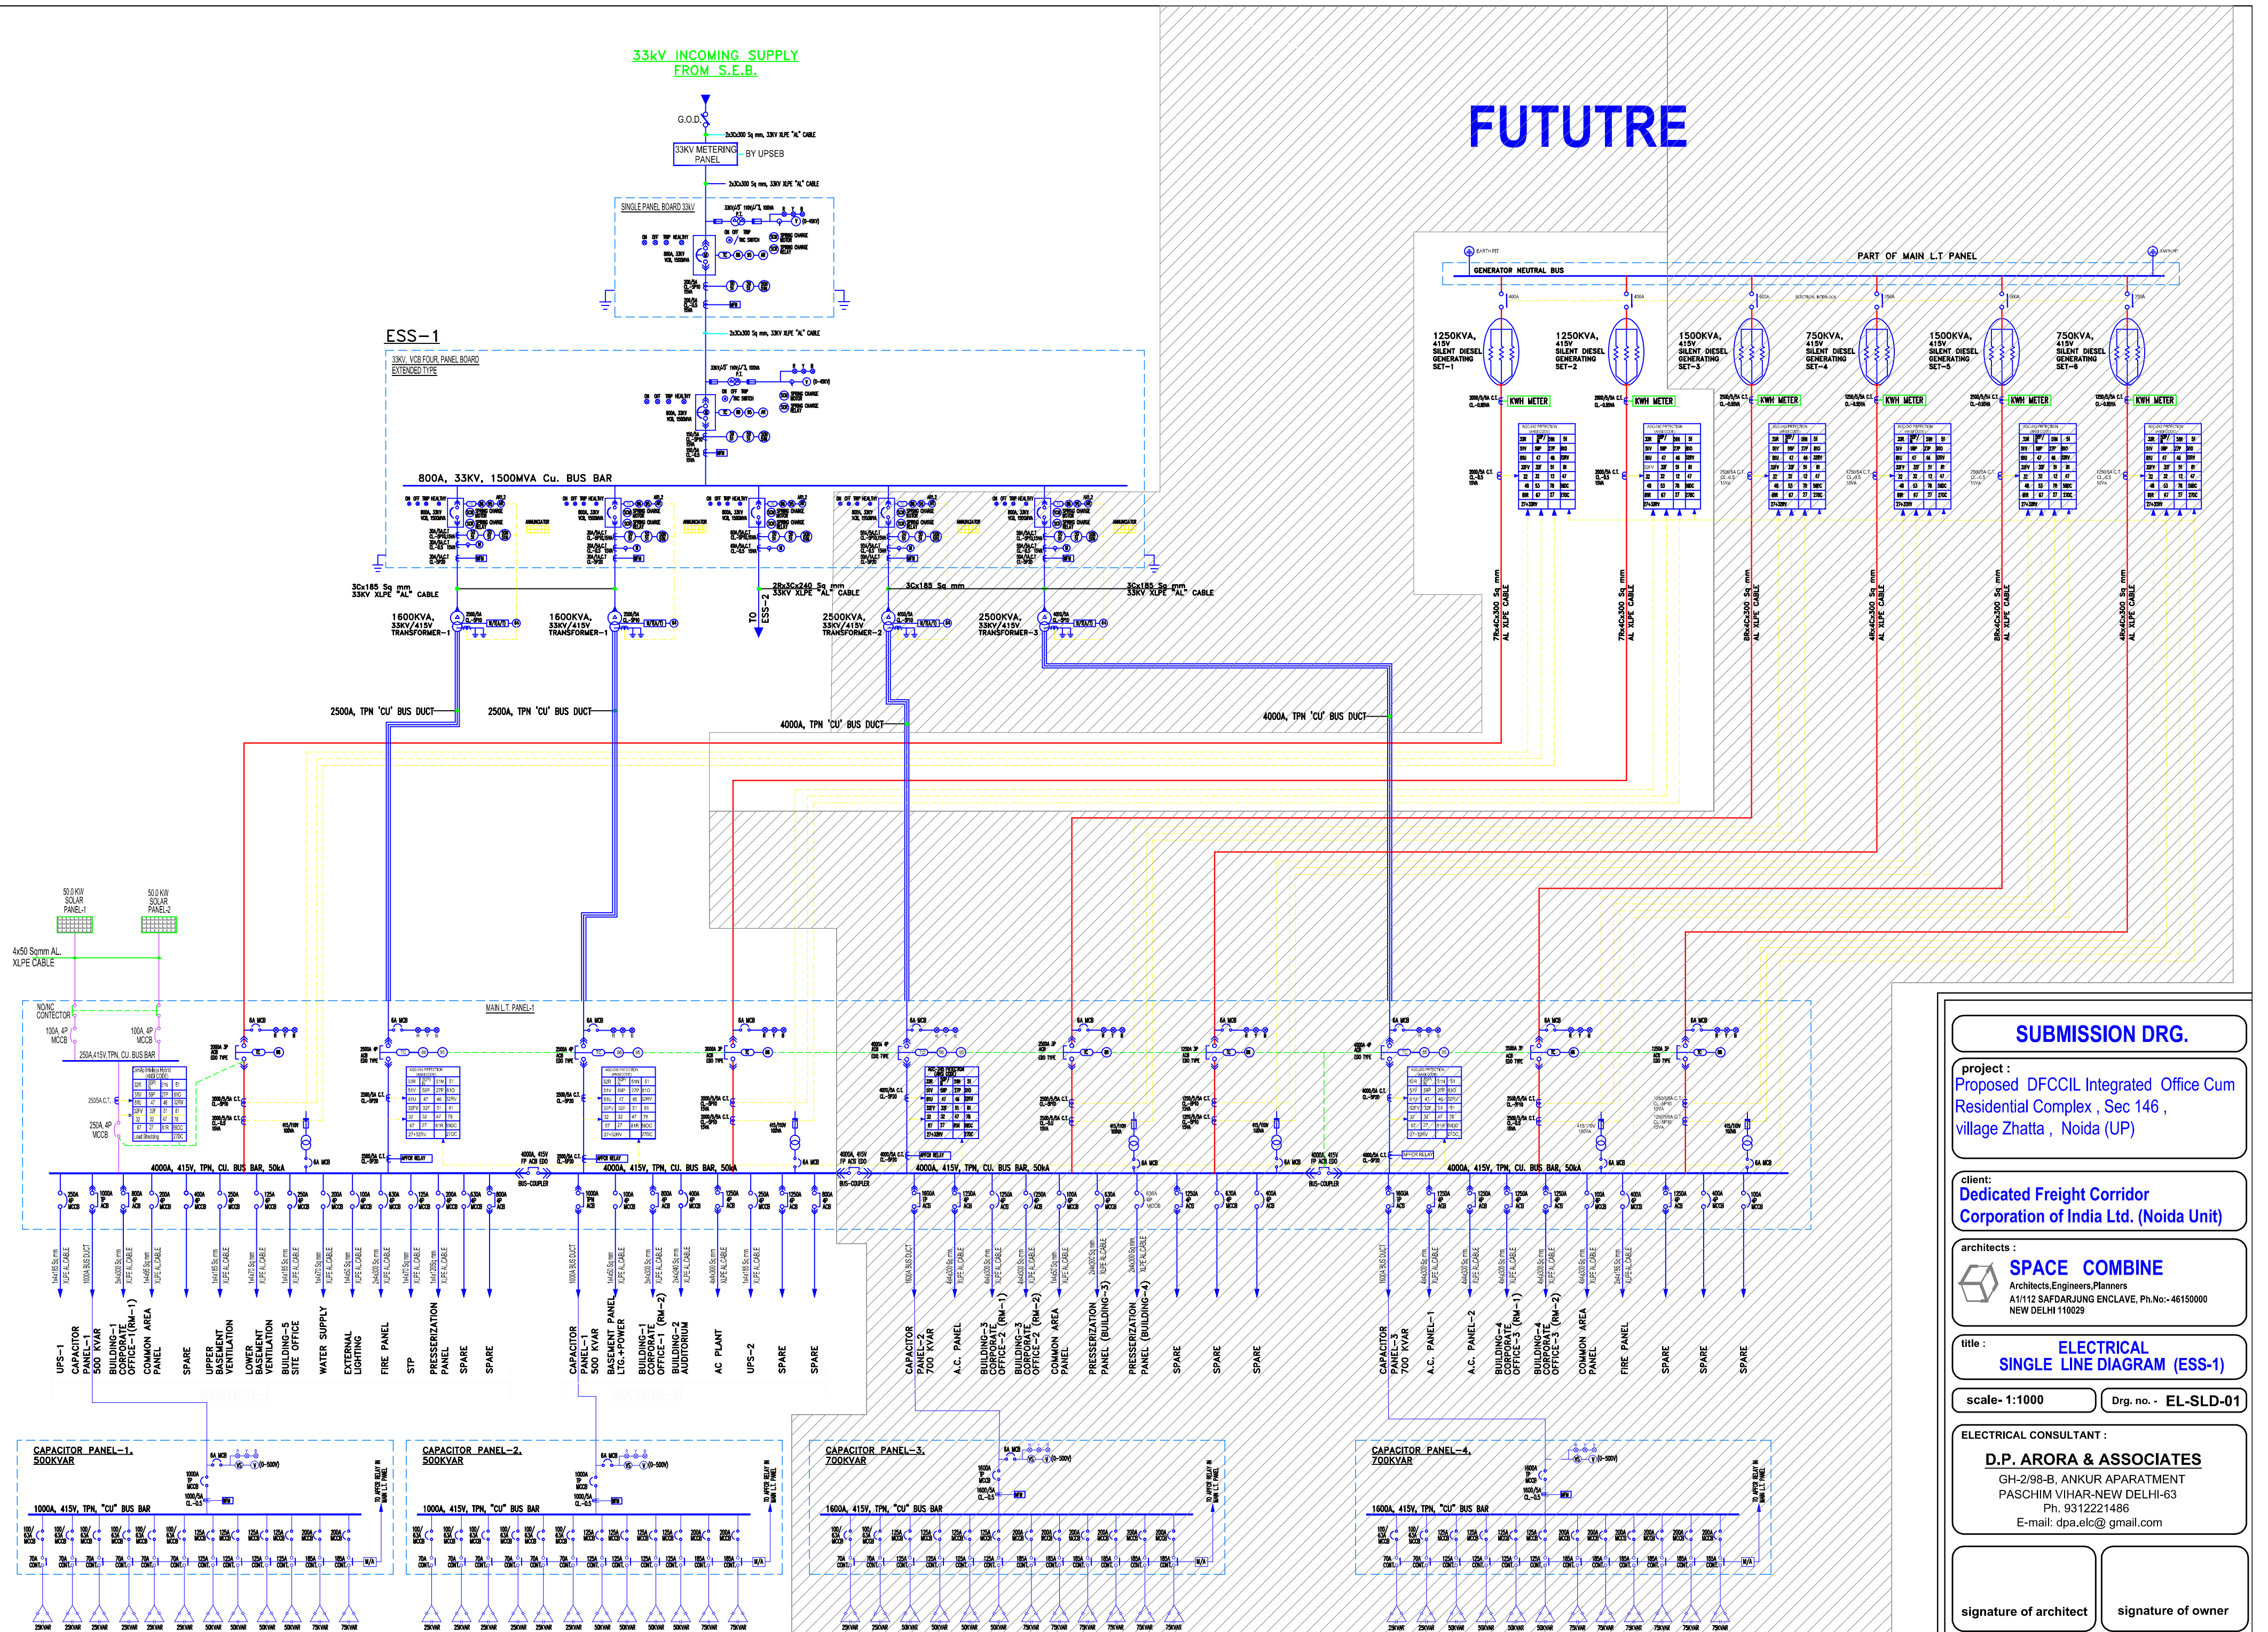

SUBMISSION DRG.

project :
Proposed DFCCIL Integrated Office Cum
Residential Complex , Sec 146 ,
village Zhatta , Noida (UP)

client:
**Dedicated Freight Corridor
Corporation of India Ltd. (Noida Unit)**


architects :  **SPACE COMBINE**
Architects,Engineers,Planners
A1/112 SAFDARJUNG ENCLAVE, Ph.No:- 46150000
NEW DELHI 110029

title : ELECTRICAL
SINGLE LINE DIAGRAM (ESS-1)

scale- 1:1000 Dwg. no. - EI-SI D-01

ELECTRICAL CONSULTANT :
D.P. ARORA & ASSOCIATES
GH-2/98-B, ANKUR APARTMENT
PASCHIM VIHAR-NEW DELHI-63
Ph. 9312221486
E-mail: dna_elc@gmail.com

signature of architect signature of owner

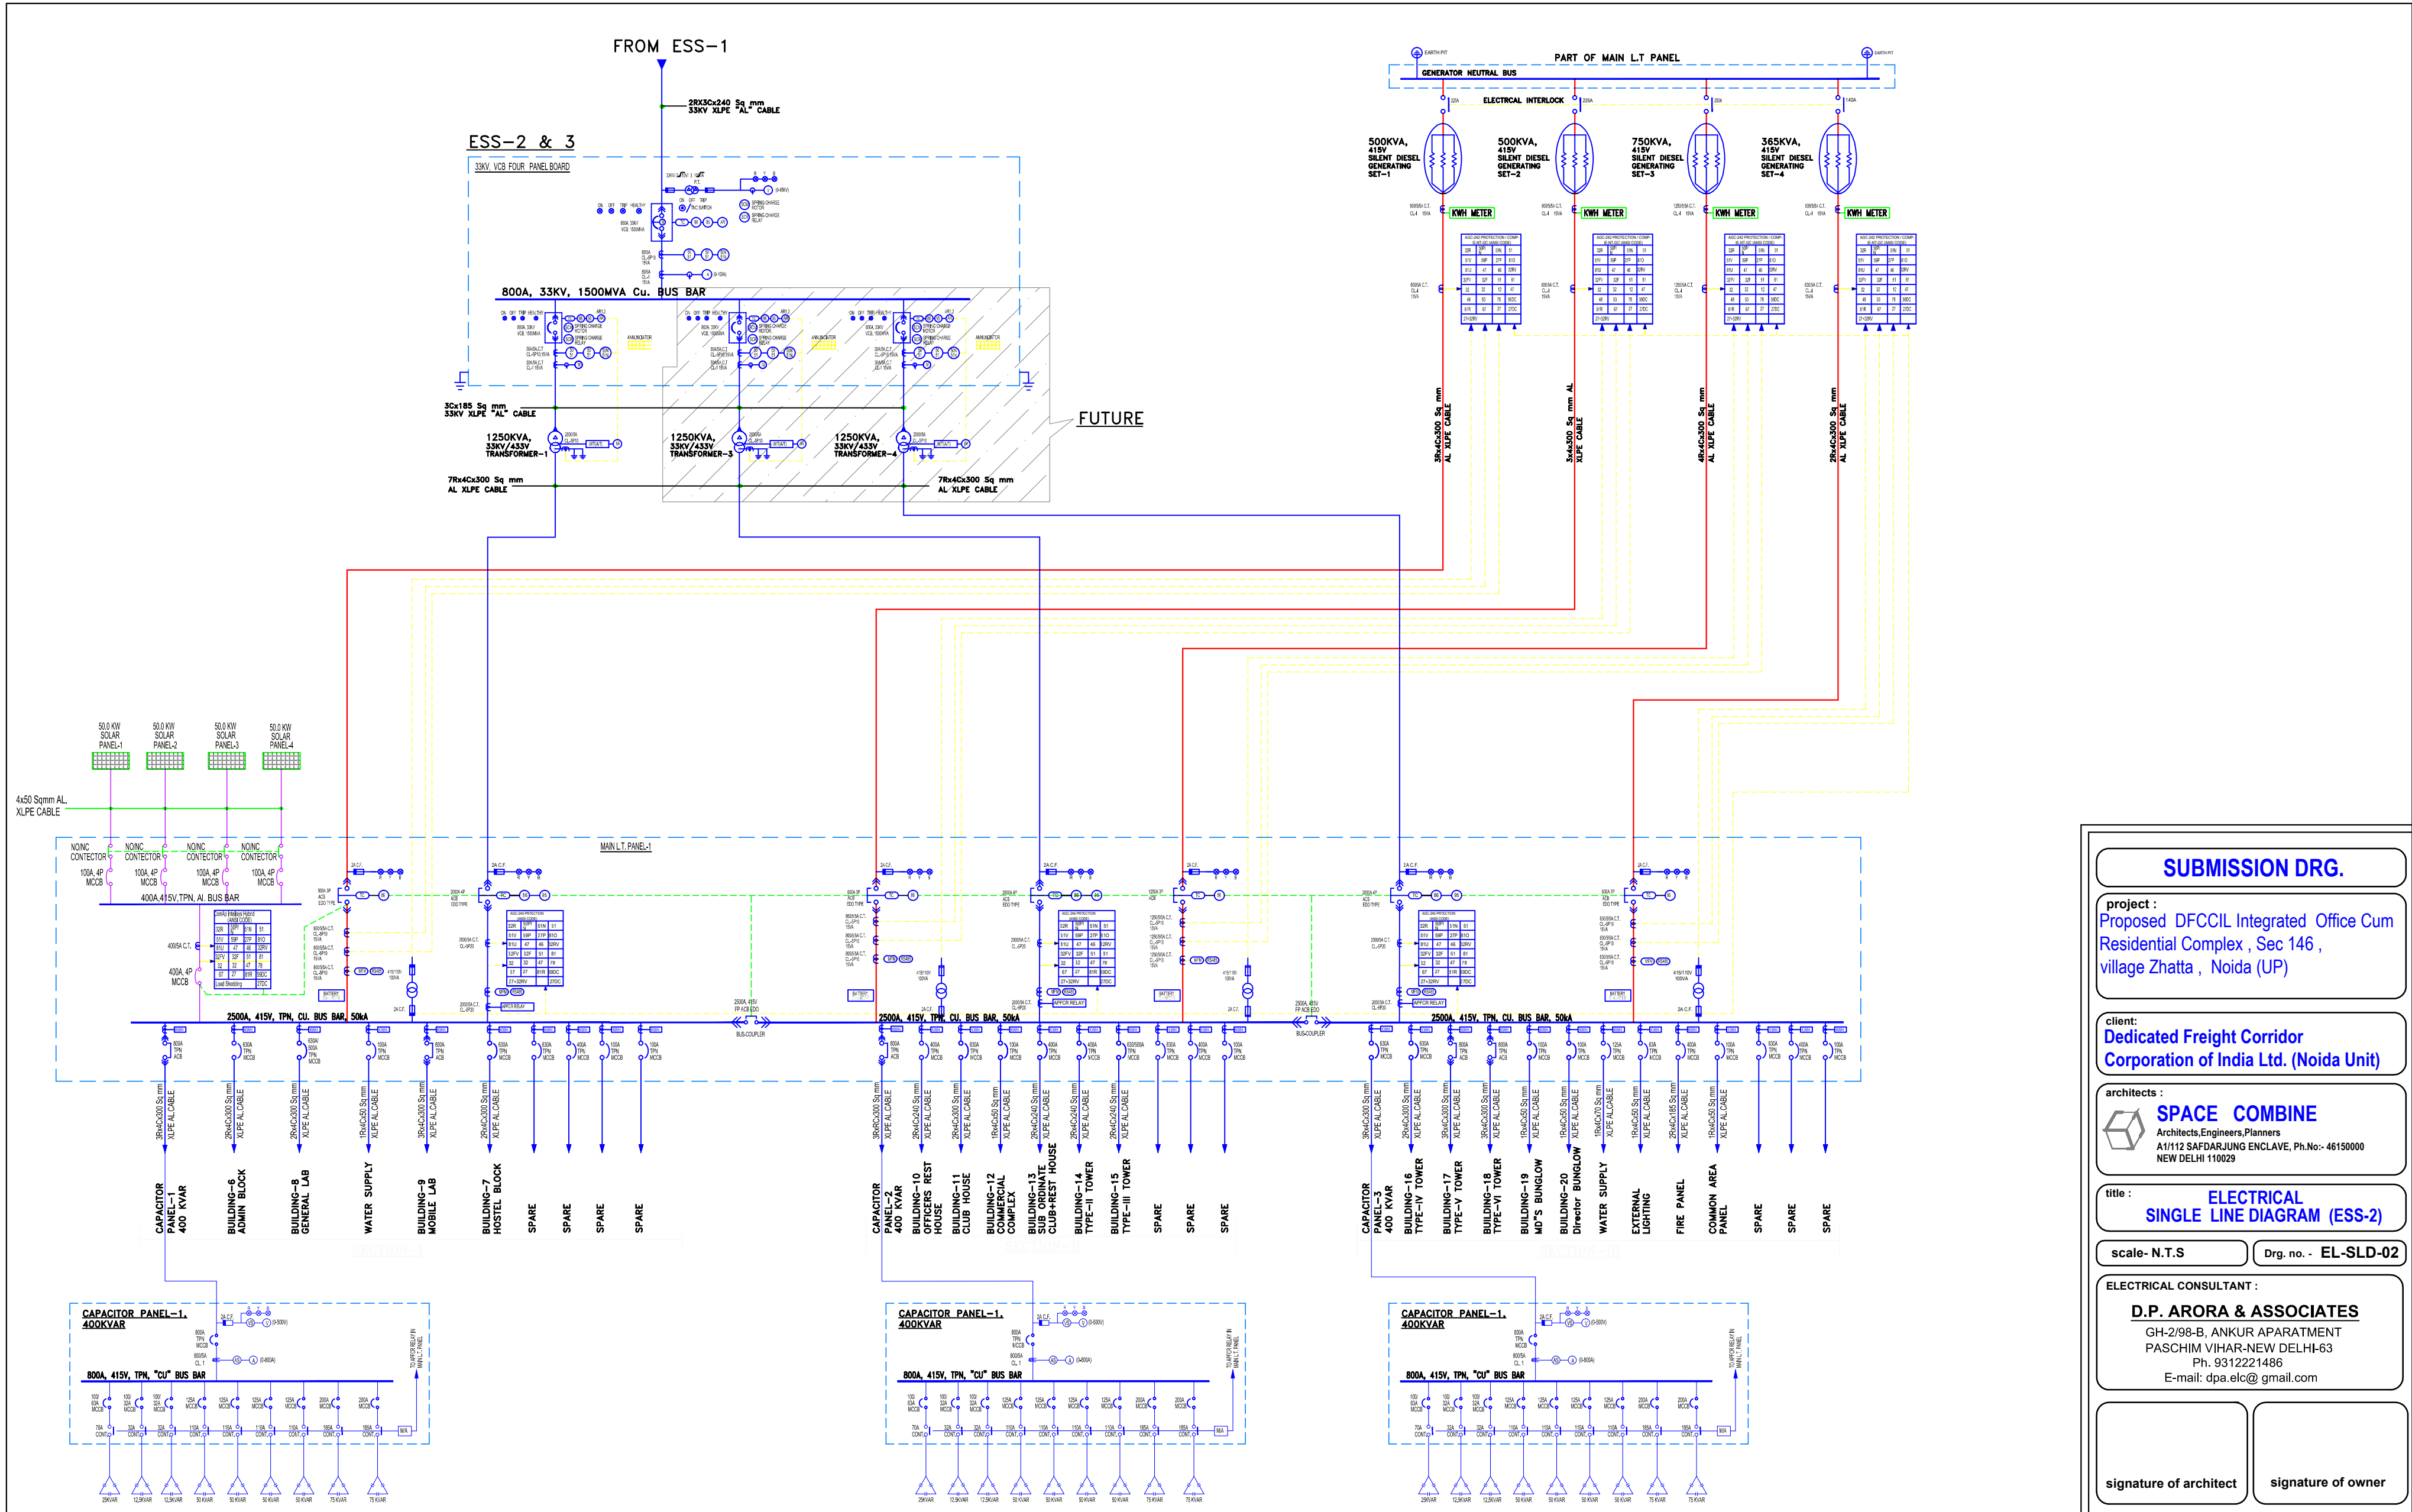

SUBMISSION DRG.

project :
Proposed DFCCIL Integrated Office Cum
Residential Complex , Sec 146 ,
village Zhatta , Noida (UP)

client:
**Dedicated Freight Corridor
Corporation of India Ltd. (Noida Unit)**

architects :
SPACE COMBINE
Architects,Engineers,Planners
A1/112 SAFDARJUNG ENCLAVE, Ph.No:- 46150000
NEW DELHI 110029

title :
**ELECTRICAL
SINGLE LINE DIAGRAM (ESS-2)**

scale- N.T.S

Drg. no. - EL-SLD-02

ELECTRICAL CONSULTANT :
D.P. ARORA & ASSOCIATES
GH-2/98-B, ANKUR APARATMENT
PASCHIM VIHAR-NEW DELHI-63
Ph. 9312221486
E-mail: dpa.elc@gmail.com

signature of architect

signature of owner